

Tarm USA, Inc
5 Main Street
Lyme, NH 03768

Tarm Piping Layout Concept Diagram

Solo Plus 60 Boiler Installation With Zone Valves
and Heat Storage System

Drawn by: TSP

Date
1-31-2008

DWG NO
D60







 

 

 


REV
3

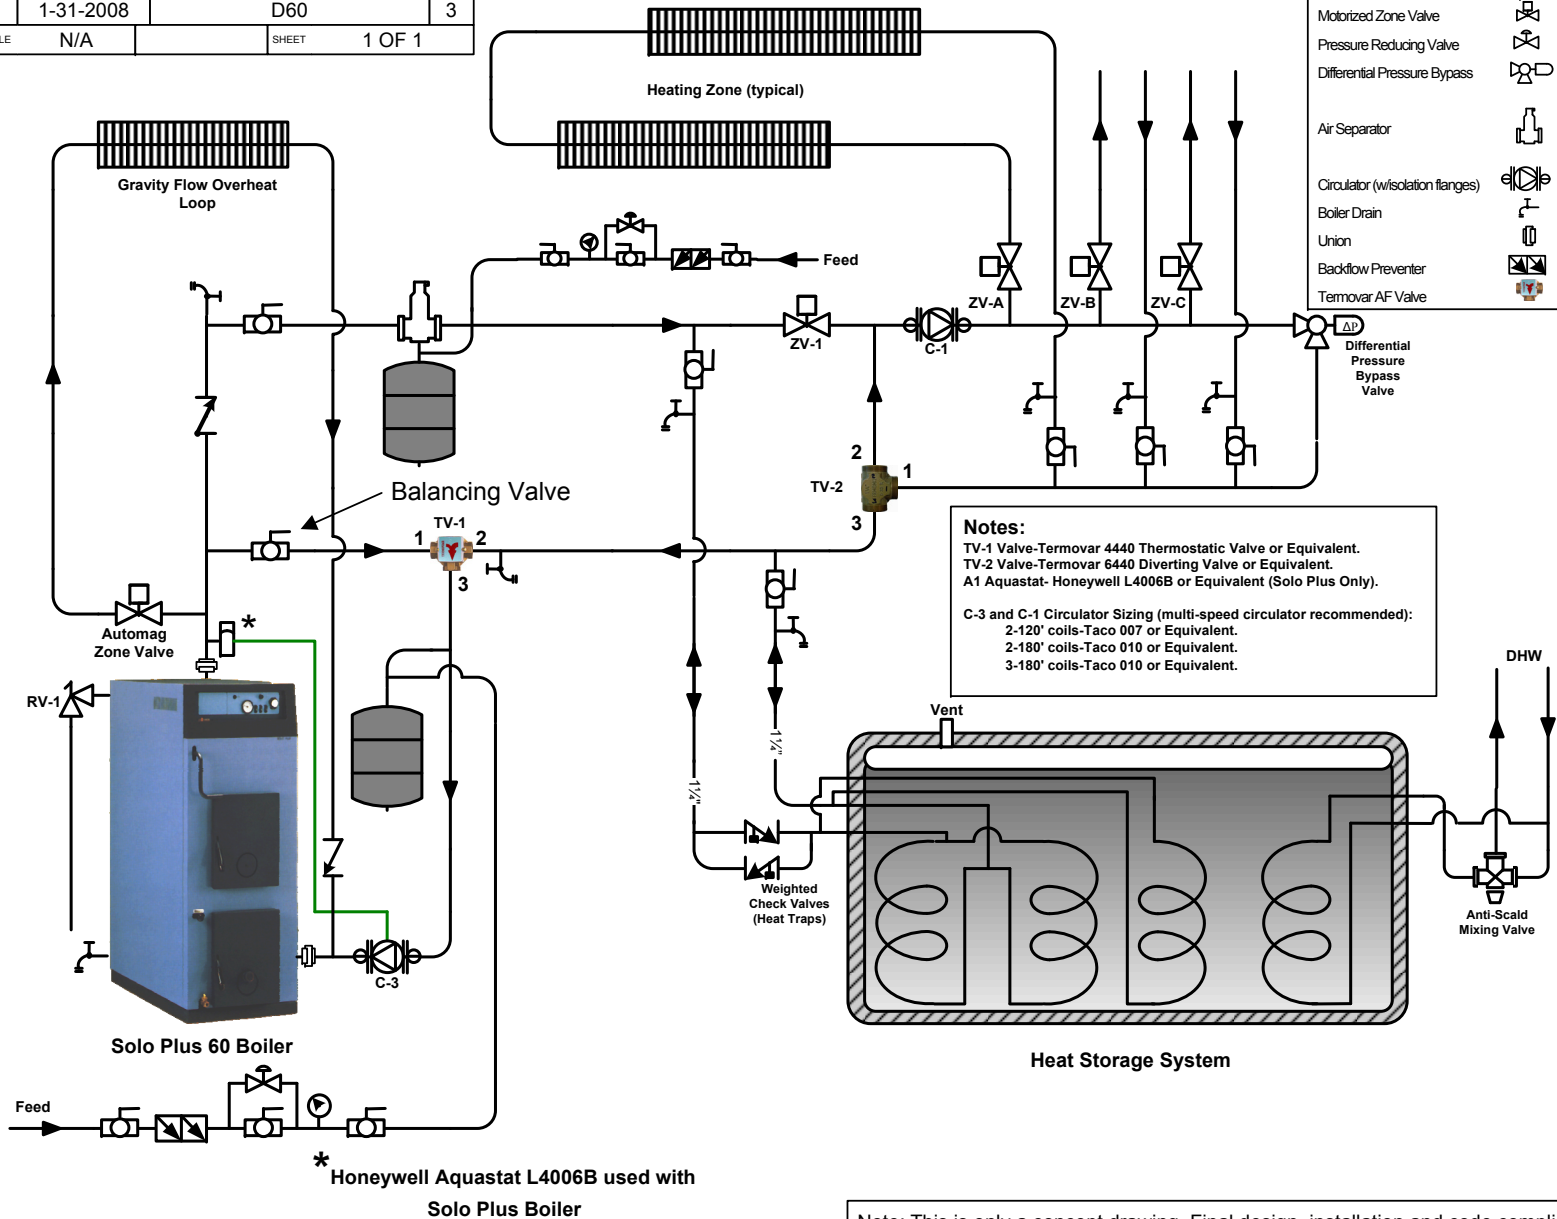
Checked by:

SCALE
N/A

SHEET
1 OF 1

Symbol Key

- Ball Valve 
- Check Valve 
- Weighted Check Valve 
- Pressure Relief Valve 
- Motorized Zone Valve 
- Pressure Reducing Valve 
- Differential Pressure Bypass 
- Air Separator 
- Circulator (w/isolation flanges) 
- Boiler Drain 
- Union 
- Backflow Preventer 
- Termove AF Valve 



Note: This is only a concept drawing. Final design, installation and code compliance details are the responsibility of the designer/installer of the system.